


DRAWING NOTES:

- | | | | |
|--|--|--|--|
| 1. UTILITY ACCESS PANEL-REFER TO PLUMBING & ELECTRICAL DRAWINGS | 11. SLOPE SLAB TO DRAIN 1/16" (3/8" MINIMUM) | 20. SUPPLY/EXHAUST FANS-REFER TO MECHANICAL DRAWINGS | 31. RATED DOOR-REFER TO DOOR SCHEDULE |
| 2. EXISTING HANGAR SLAB TO REMAIN | 12. REFER TO STRUCTURAL DRAWINGS FOR SLAB CONTROL JOINTS | 21. FENCING & GATES-REFER TO CIVIL DRAWINGS | 32. NOT USED |
| 3. CONCRETE FILLED 6" DIAMETER STEEL PIPE BOLLARDS - REFER TO ARCHITECTURAL DRAWINGS FOR DETAIL- 4 TYPICAL PER OVERHEAD DOOR | 13. PREP NEW CONCRETE HANGAR SLAB FOR HIGH PERFORMANCE COATING | 22. FALL PROTECTION SYSTEM #1 - ANCHORED TO PEMB - INSTALLER TO SUBMIT SHOP DRAWINGS TO ARCHITECT FOR APPROVAL | 33. STANDARD LINER PANEL BY PEMB-MATCH HEIGHT OF RATED PANEL-APPROX +/- 17'-4" ENTIRE LENGTH OF EAST WALL & POCKETS - REFER TO WALL SECTIONS |
| 4. NEW TRENCH DRAIN - REFER TO STRUCTURAL DRAWINGS FOR DETAIL | 14. ONE HOUR RATED WALL | 23. PEMB X-BRACING - TYP - REFER TO PEMB DRAWING FOR LOCATIONS | 34. APPROXIMATE LOCATION OF HIGH-VOLUME, LOW-SPEED FANS (4) LOCATIONS-ANCHORED TO PEMB & CENTERED BETWEEN MAIN FRAME-REFER TO MECHANICAL & ELECTRICAL DRAWINGS - 20'-0" DIAMETER |
| 5. SLAB & FOUNDATION- REFER TO STRUCTURAL DRAWINGS | 15. TWO HOUR RATED WALL | 24. INSULATED/HEATED FIRE WATER LINE INTO BUILDING - REFER TO FIRE SUPPRESSION DRAWINGS | 35. ONE HOUR RATED WINDOW & FRAME |
| 6. HEATED FIRE WATER STORAGE TANK- REFER TO FIRE SUPPRESSION DRAWINGS | 16. STAINLESS STEEL SINK - REFER TO PLUMBING FIXTURE SCHEDULE | 25. DOMESTIC WATER LINE INTO BUILDING - REFER TO CIVIL & PLUMBING DRAWINGS | 36. FIRE DEPARTMENT CONNECTION LOCATION-COORD WITH FIRE SUPPRESSION DRAWINGS |
| 7. GENERATOR ON NEW CONCRETE PAD | 17. SAFETY SHOWER & EYEWASH STATION WITH FLOOR DRAIN BELOW - REFER TO PLUMBING DRAWINGS FOR DRAIN TIE-IN . MODEL GUARDIAN GBF2173 SURFACE MOUNTED SAFETY STATION | 26. ELECTRIC METER LOCATION - COORD W/ ELECTRICAL DWGS | 37. HANGAR DOOR TRACK SNOW MELT BOILER - REFER TO ELECTRICAL & PLUMBING DRAWINGS |
| 8. TRANSFORMER ON NEW CONCRETE PAD | 18. LAV CART 3" PVC STUB UP WITH FLOOR DRAIN AND HOSE BIBB - REFER TO PLUMBING DRAWINGS | 27. WALL & FLOOR SPACE RESERVED FOR FIRE SUPPRESSION VALVES ETC. | 38. FOAM GENERATORS ABOVE-REFER TO FIRE SUPPRESSION DRAWINGS FOR LOCATION |
| 9. NEW GAS METER & REGULATOR SERVICE ENTRANCE INTO BUILDING | 19. DIESEL POWERED FIRE PUMPS WITH EXHAUST THROUGH EXTERIOR WALL, PROVIDED BY FIRE SUPPRESSION INSTALLER - REFER TO FIRE SUPPRESSION & MECH DWGS FOR DETAILS | 28. PEMB CANOPY/OVER HANG-REFER TO ROOF PLAN & EXTERIOR ELEVATIONS | 39. AIR COMPRESSOR & DRYER-REFER TO ELECTRICAL & MECHANICAL DRAWINGS |
| 10. UNDERGROUND OIL/WATER SEPARATOR - REFER TO PLUMBING DRAWINGS | | 29. ENTRANCE CANOPY-REFER TO EXTERIOR ELEVATIONS | 40. FOAM CONCENTRATION TANKS-REFER TO FIRE SUPPRESSION DRAWINGS |

GENERAL NOTES:

- A. REFER TO ENLARGED PLANS FOR PARTITION TYPES & DETAIL CALL OUTS
 B. FURNITURE SHOWN FOR PLANNING PURPOSES ONLY - NOT IN CONTRACT

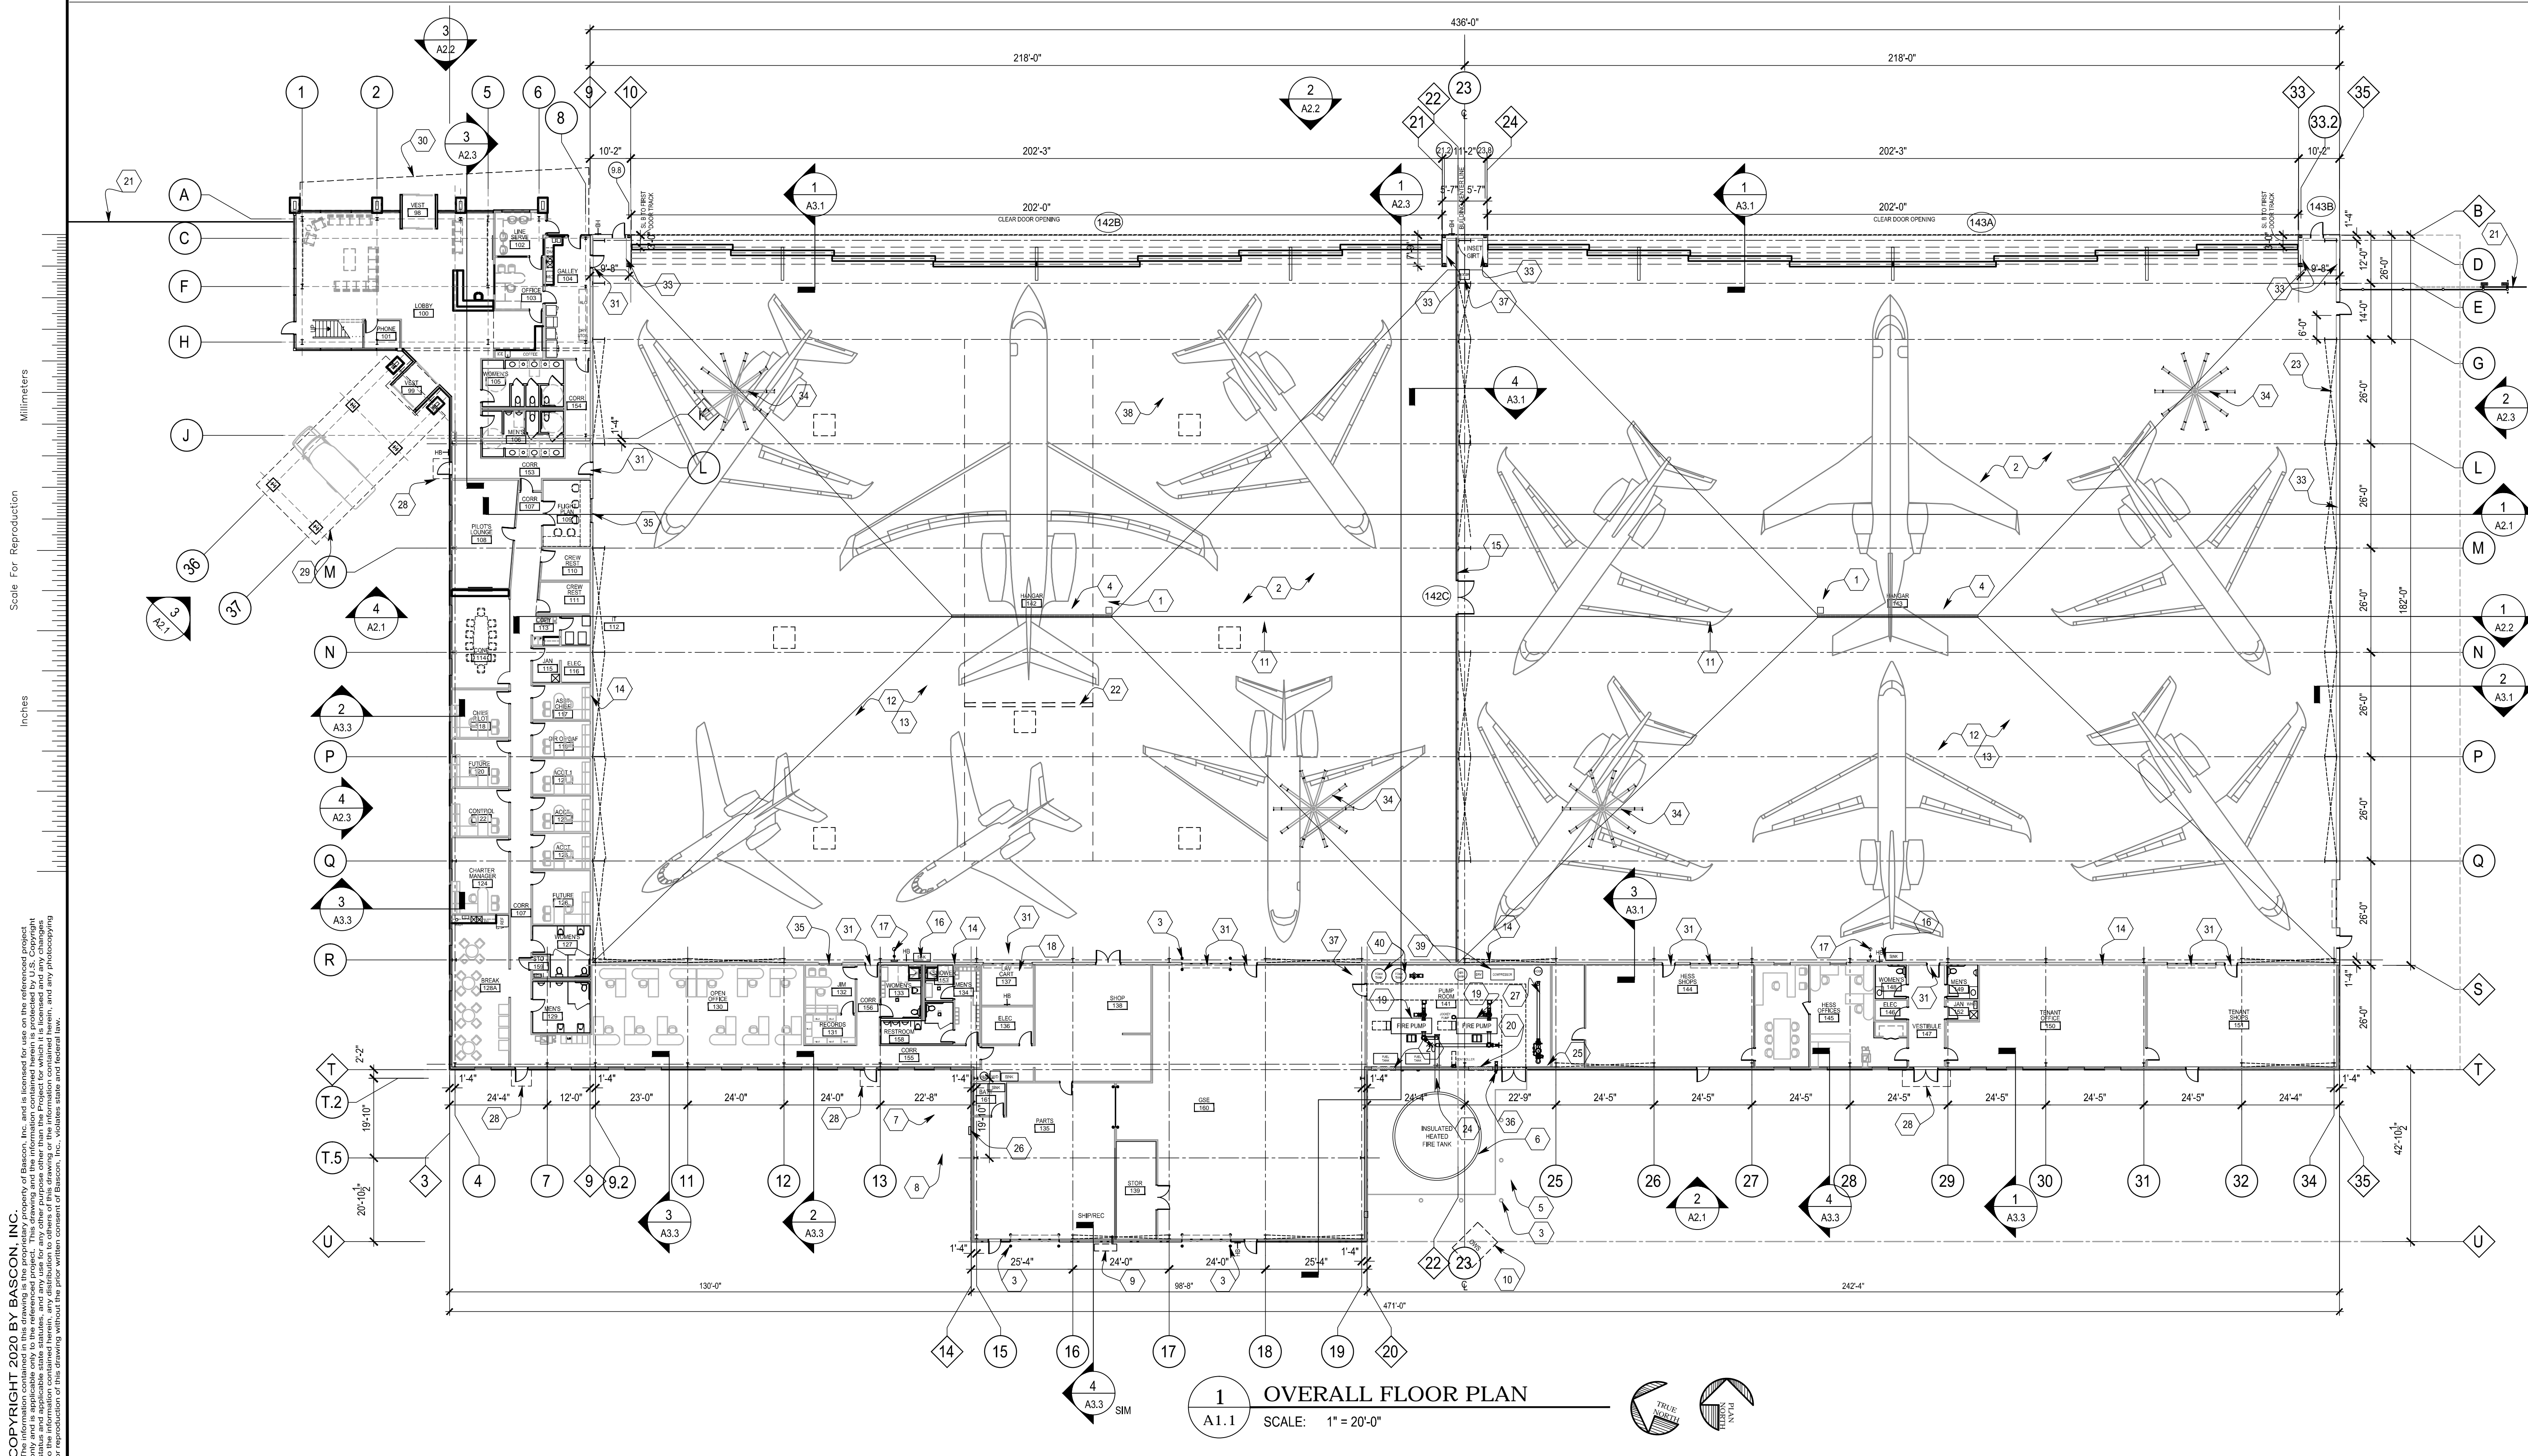

COPYRIGHT 2020 BY BASCON, INC. All rights reserved. This drawing and the information contained herein is provided by BASCON, INC. for the use of the client. It is the responsibility of the client to ensure that the information contained herein is accurate and complete. No liability is assumed by BASCON, INC. for any errors or omissions in this drawing or for any consequences arising from its use.

ISSUE

BASCON, INC.
 607-500-Redna Terrace
 Cincinnati, Oh. 45215-1171
 513/772-1674 FAX: 772-1684
 Website: www.basconinc.com

bascon
 architects-engineers-developers
 constructors-construction managers

ARCHITECTURAL
 OVERALL FLOOR PLAN

FLIGHTSERY
 HANGARS, SHOPS & OFFICES
 TRENTON-MERCER AIRPORT, 1 JACK STEPHAN WAY
 TRENTON, NJ 08628

STATE OF NEW JERSEY
 REGISTERED PROFESSIONAL ARCHITECT
 20176

DATE: 06-19-20
 DRAWN BY: SS
 PROJECT NO.: 180006
 SHEET NO.: **A1.1**